


**SCHEDULE OF COMPONENTS**

- THICKLIFT 50MM THICKLIFT BITUMINOUS PAVING OVER 150mm COMPACTED FINISHED LIMESTONE BASE FALL TO SILL FTS
- FINISHED LEVEL TOP OF GRADE
- FINISHED LEVEL TOP OF PAVING
- FINISHED LEVEL TOP OF GROUND
- BRICK PAVING AS SPECIFIED OVER TO LOCAL AUTHORITY DOOR THRESHOLD FOR DISABLED ACCESS.
- 150PVC STORMWATER LINE

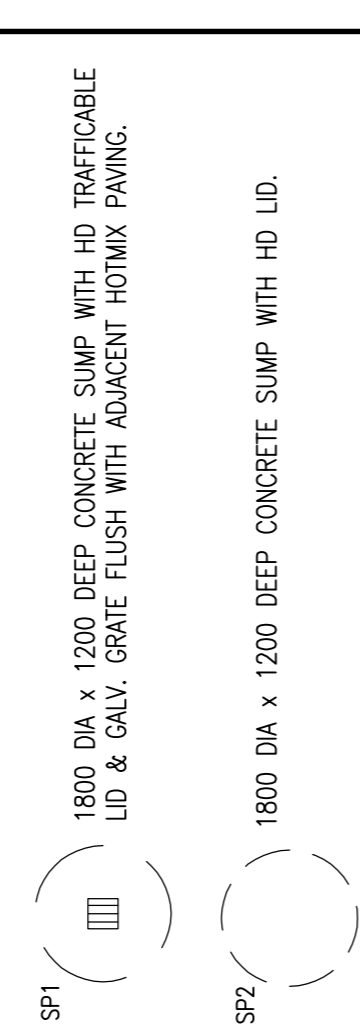

90P PVC RETIC. CONDUIT 800 DEEP ENDS TO BE CLEARLY MARKED FOR FUTURE REFERENCE

BK CONCRETE BARRIER KERB  
OR 180mm DIA. x 1200 HIGH CONC. FULLED GALV. ROLLBAR SET IN 500x500x60 DEEP MASS CONC. PAD FOOTING.

HO-MMM WATER METER - 50MM WATER SERVICE IN. H.P. PVC FIT STOP COOK FOR RETIC WITHIN 1000 OF METER.

HO-FSM FIRE SERVICE WATER METER TO WATER CORP REQUIREMENTS. WATER METER TO WATER CORP REQUIREMENTS WITH LID AT PAVING LEVEL. SET IN 500x500x60 DEEP MASS CONC. PAD FOOTING.

EXTD O HB PLUMBING FITTING LOCATION  
HCX BRASS HOSE COCK - 750 AG.  
FSM FIRE HOSE REEL  
3" GALVANIS. DIAM. HEAD FIRE HYDRANT RISER INSTALLED IN ACCORDANCE WITH AS 2118

EXIT ILLUMINATED EXIT SIGN IN ACCORDANCE WITH BCA REGULATIONS.

ORMP1 230mm DIA PVC RAINWATER PIPE FIX TO WALL PANEL AT 1500 CENTRES VERTICAL  
ORMP2 150mm DIA PVC RAINWATER PIPE FIX TO WALL AT 1500 CENTRES VERTICAL

ORWH RAINWATER HEAD TO DETAIL WITH 90mm DIA FIX TO WALL AT 1500 CENTRES VERTICAL. PAINT FINISH.

ISSUED FOR CONSTRUCTION	2/08/07
DATE	DATE
PROJECT	LOT
<b>PROPOSED OFFICE &amp; WAREHOUSE</b> <b>OBAN PTY LTD</b> <b>at LOT 989-990 MORDAUNT CIRCUIT</b> <b>AND OBAN LINK, CANNING VALE</b>	
DRAWING <b>SITE PLAN</b>	
COMMERCIAL designMANAGEMENT	
② Pamment st Nth Fremantle 6159 (08) 9335 2977 (08) 9335 2644 TO VERIFY DIMENSIONS AND SET OUT AND REFER DISCREPANCIES TO DESIGNER	
30MM BJC	JOB NO. 0466
SCALE 1:100	DATE JULY 2007
	DWG NO. A02' A14

**SITE PLAN**  
SCALE 1:100