


1 Ground Floor
1 : 100

Drawing Sheet Title
Ground Floor Plan

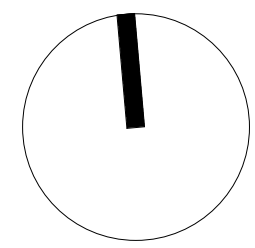


Amendments		
Issue	Revision	Date
A	Preliminary	26.10.09

CLIENT Fast Fix Finance	DATE 26.10.09	DRAWN GH	SCALE 1 : 100
PROJECT Fast Fix Finance	JOB No. 09065	CHECKED -	APP'D -
LOCATION 12 Queen St, Goodna	DRAWING No. A101	ISSUE	

ceolin myers



 

 
CeolinMyers Pty Ltd
ACN 136 661 928
www.ceolinmyers.com

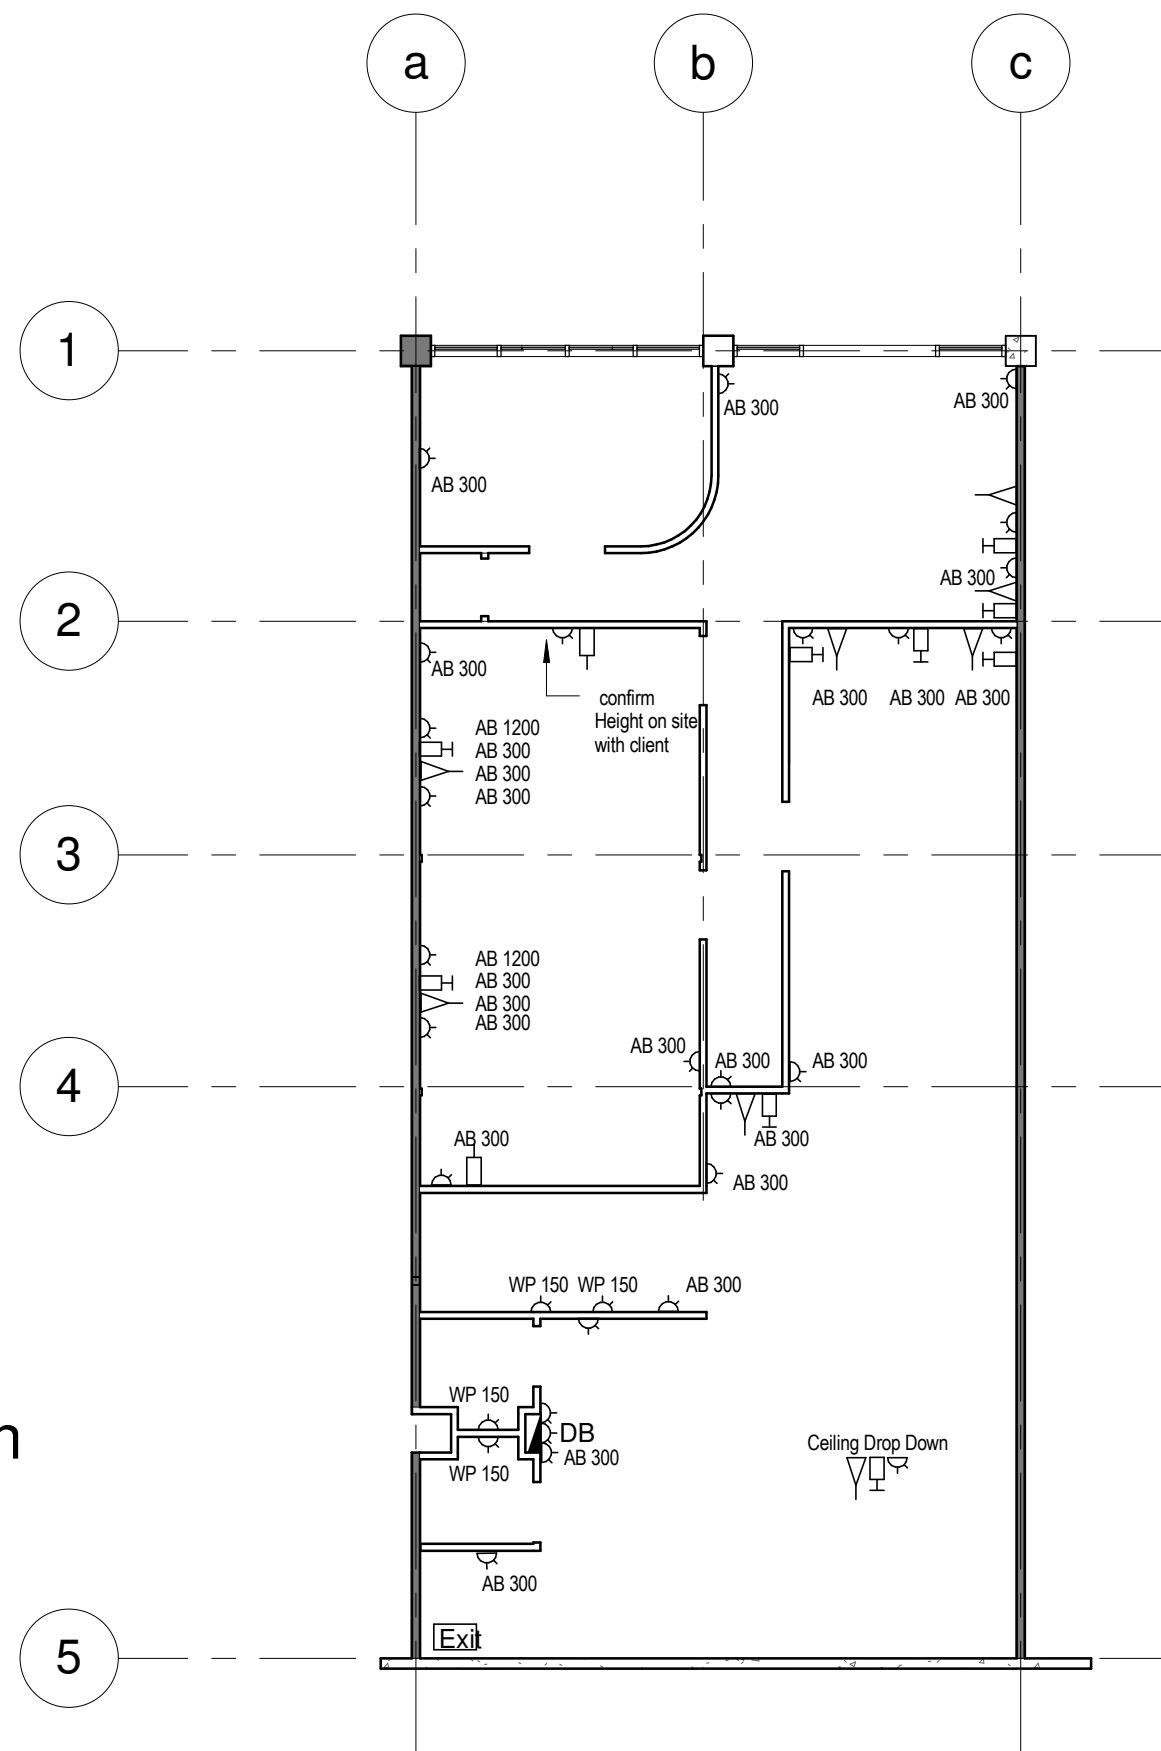Po Box 640 Spring hill
Brisbane Q 4004
info@ceolinmyers.com




Electrical Legend

Note:
Confirm all outlets heights before installation with contractor.

-  - Double GPO
- AB - Height above floor
- WP - Above Bench
-  - Single GPO
-  - Telephone outlet
-  - Data Point
-  - Television outlet

1 Electrical & Data Plan
1 : 100

Drawing Sheet Title
Electrical and Data Layout

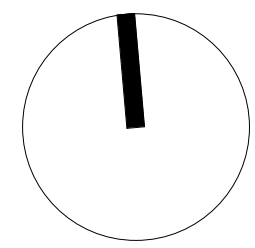

Amendments		
Issue	Revision	Date
A	Preliminary	26.10.09

CLIENT Fast Fix Finance	DATE 26.10.09	DRAWN GH	SCALE 1 : 100
PROJECT Fast Fix Finance	JOB No. 09065	CHECKED -	APP'D -
LOCATION	DRAWING No. A102	ISSUE	




ceolin myers

CeolinMyers Pty Ltd
ACN 136 661 928
www.ceolinmyers.com

Po Box 640 Spring hill
Brisbane Q 4004
info@ceolinmyers.com

1 **Ground Floor**
1 : 100

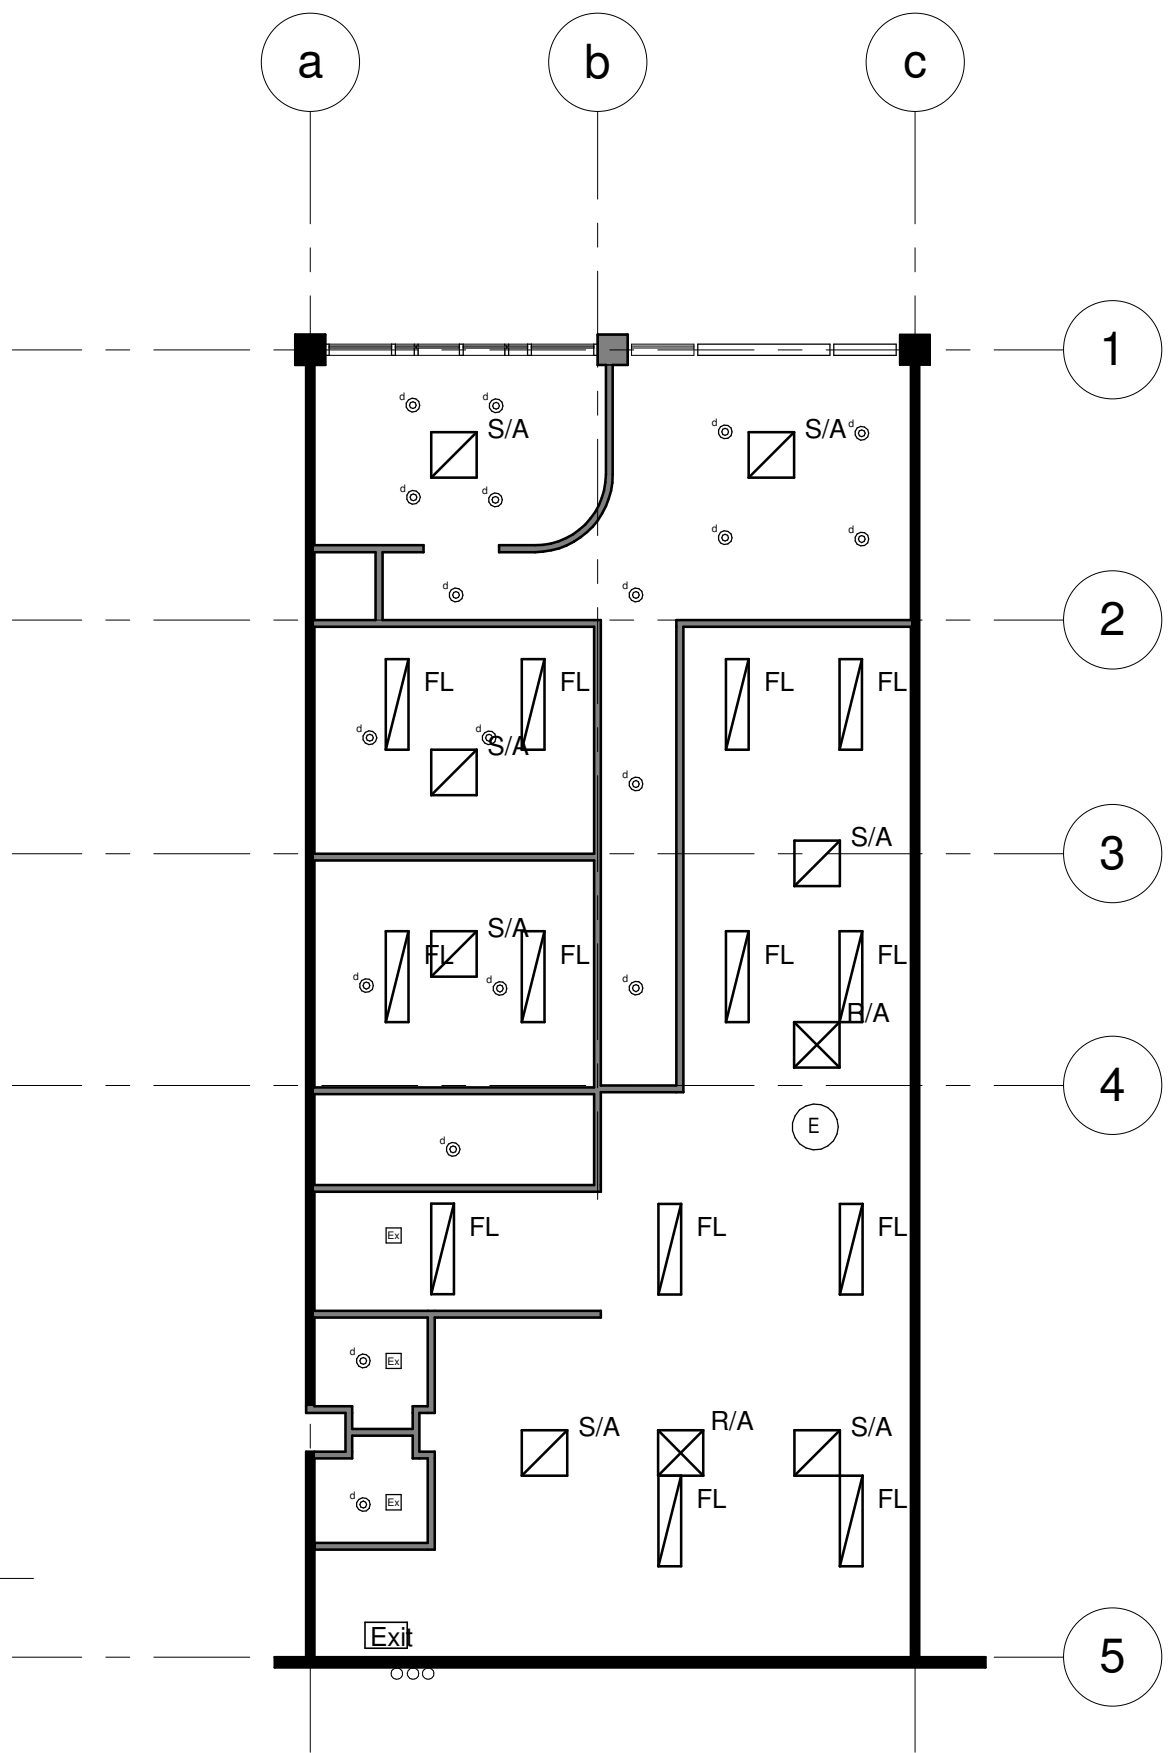

Lighting Legend

Electrical and lighting layouts are indicative. Verify final locations of all lights, fittings and switches to be confirmed with the client - before wiring.


All light fittings switches and sundry fittings supplied by client.

Energy efficiency - e.g. LED downlight and/or compact fluores wherever possible.

- Downlight with dimmer
- Ceiling mounted pendant
- Ceiling mounted light
- Spotlight
- Wall mounted light @ 2100
- Fluorescent light
- Light switch
- Light control with dimmer
- 2 way switch
- Emergency Lighting
- External ventilation (to be turned on automatically with lights)
- Ceiling Fan
- Supply Air
- Return Air

Drawing Sheet Title

Reflected Ceiling Plan

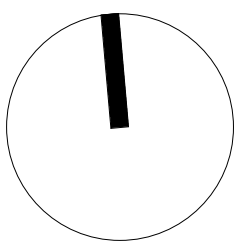


Amendments		
Issue	Revision	Date
A	Preliminary	26.10.09

CLIENT Fast Fix Finance	DATE 26.10.09	DRAWN GH	SCALE 1 : 100
PROJECT Fast Fix Finance	JOB No. 09065	CHECKED -	APP'D -
LOCATION	DRAWING No. A103	ISSUE	


CeolinMyers Pty Ltd
ACN 136 661 928
www.ceolinmyers.com

Po Box 640 Spring hill
Brisbane Q 4004
info@ceolinmyers.com

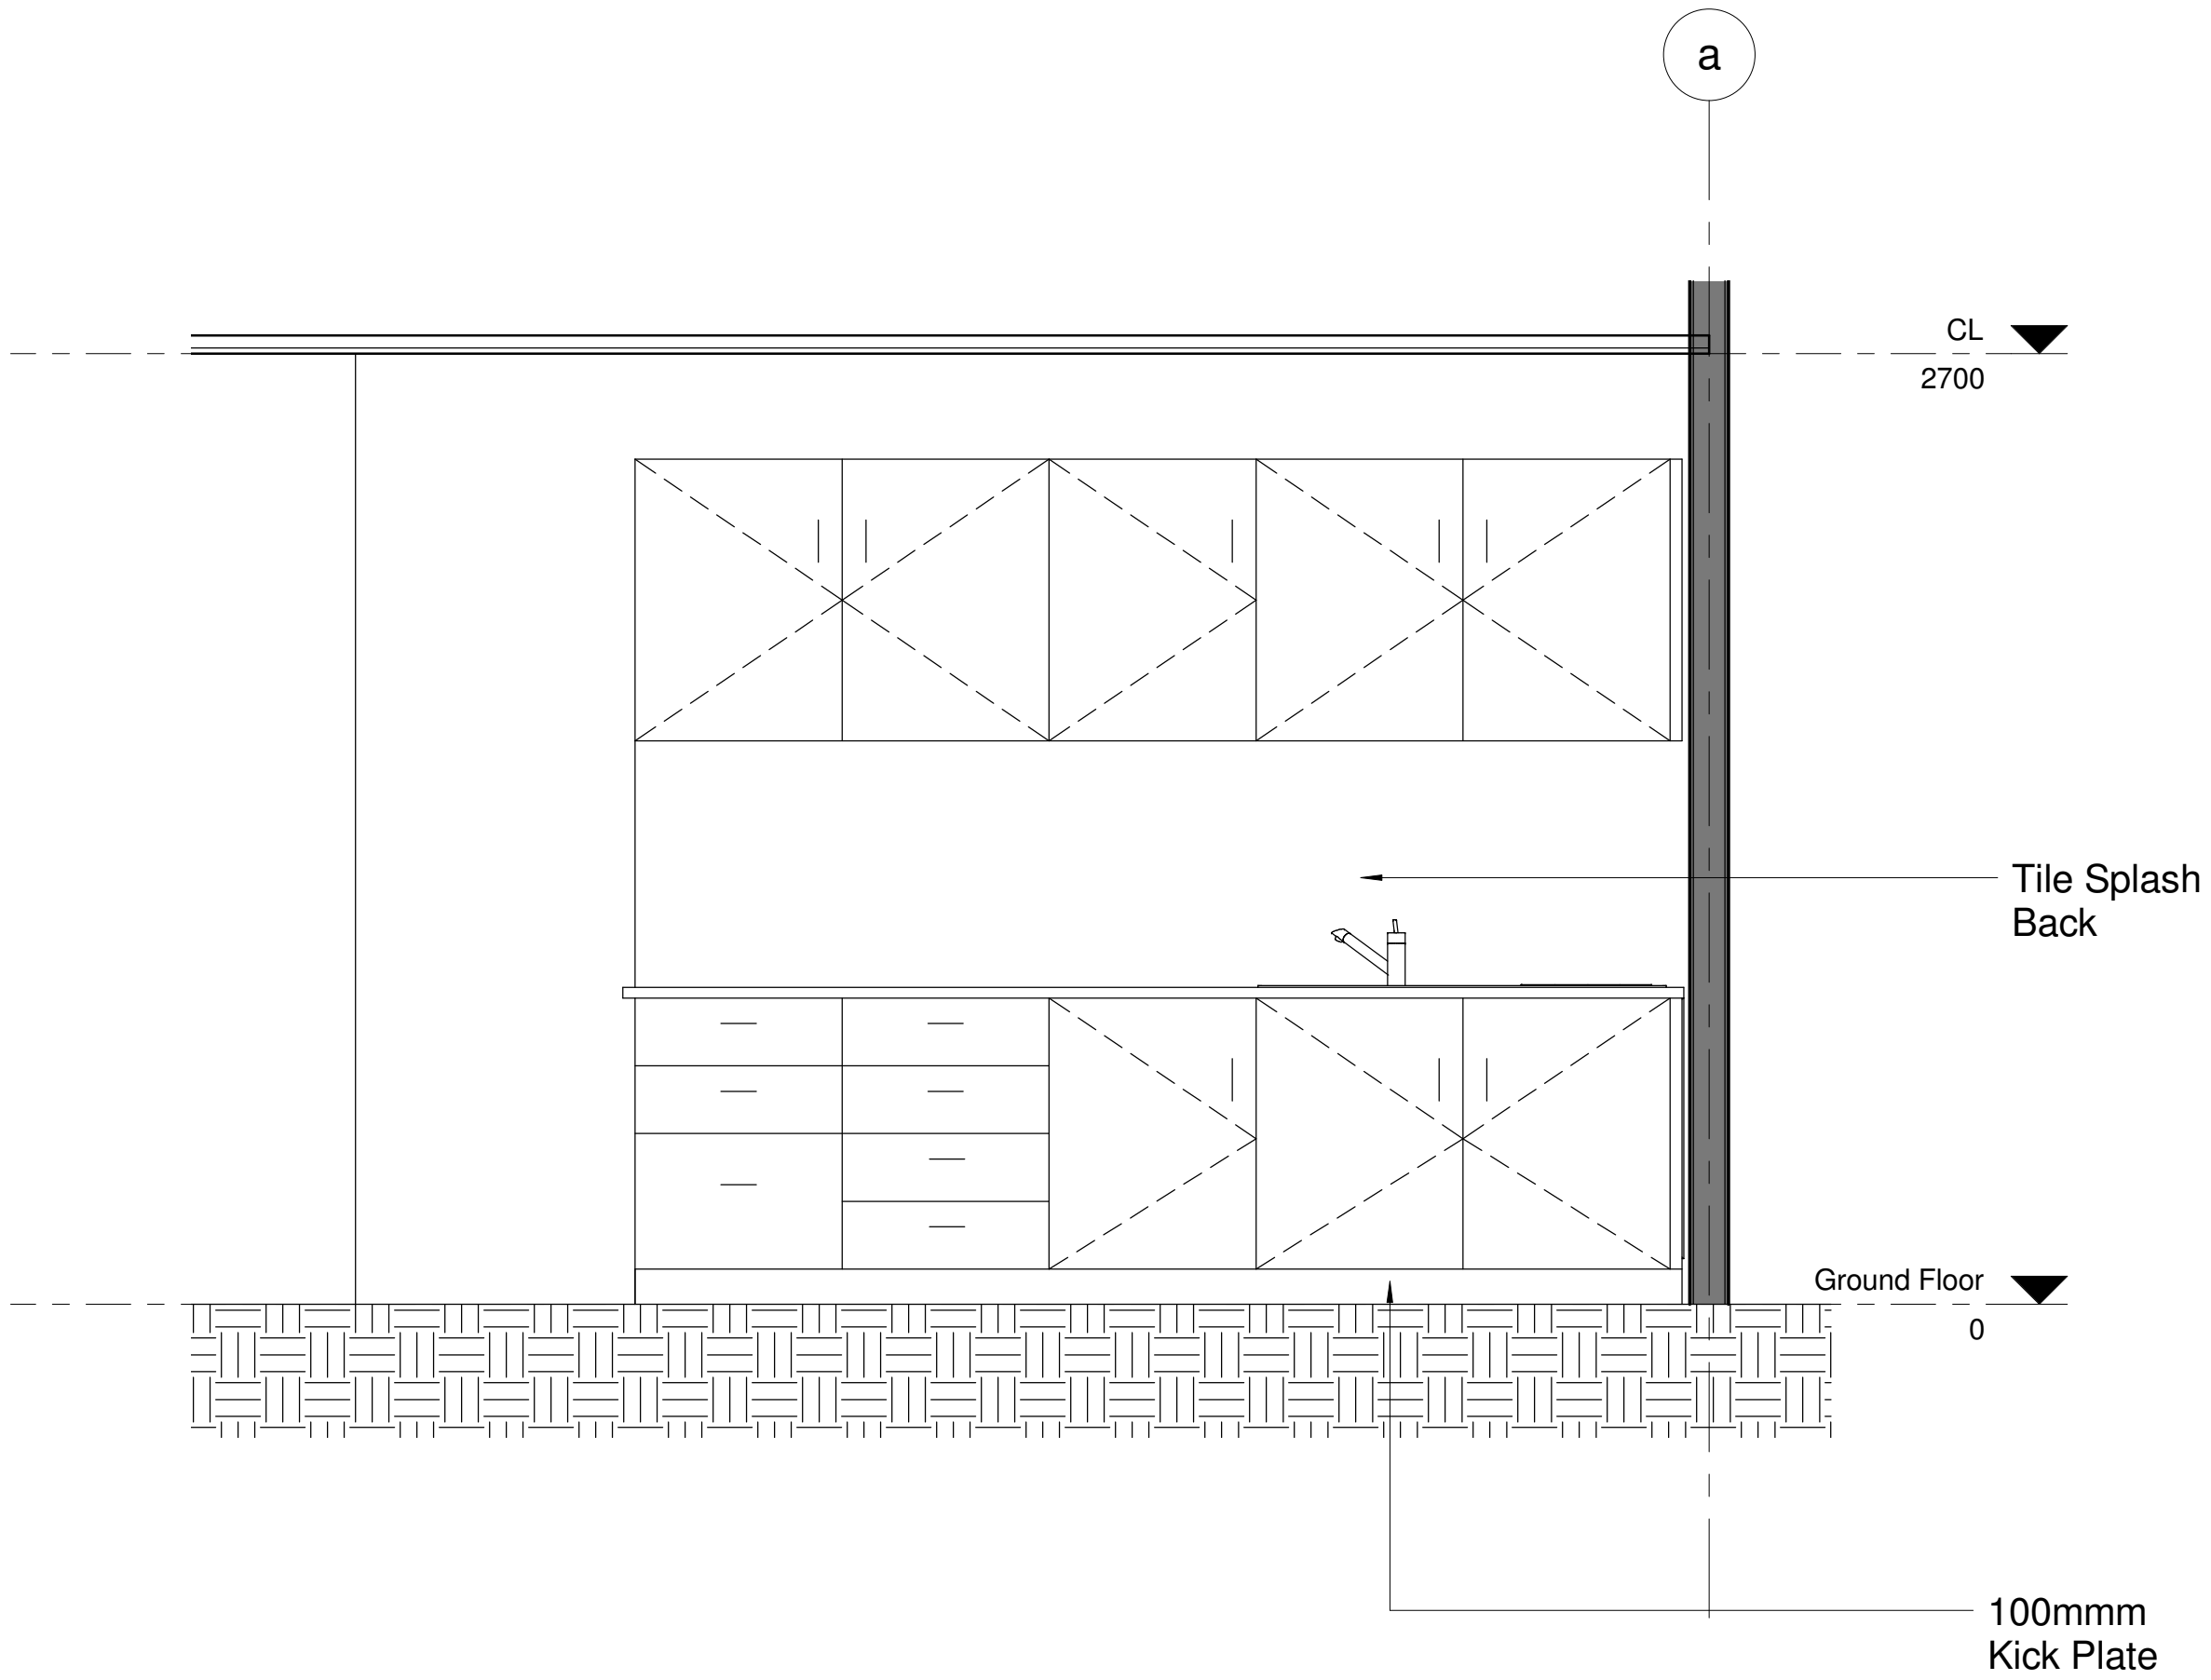

Drawing Sheet Title

Kitchen Details

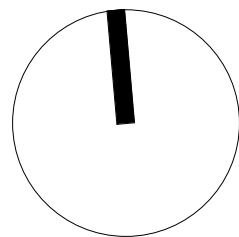


Amendments		
Issue	Revision	Date
A	Preliminary	26.10.09


CLIENT Fast Fix Finance	DATE 26.10.09	DRAWN GH	SCALE 1 : 20
PROJECT Fast Fix Finance	JOB No. 09065	CHECKED -	APP'D -
LOCATION	DRAWING No. A104	ISSUE	

ceolin myers
 CeolinMyers Pty Ltd
 ACN 136 661 928
 www.ceolinmyers.com

Po Box 640 Spring hill
 Brisbane Q 4004
 info@ceolinmyers.com

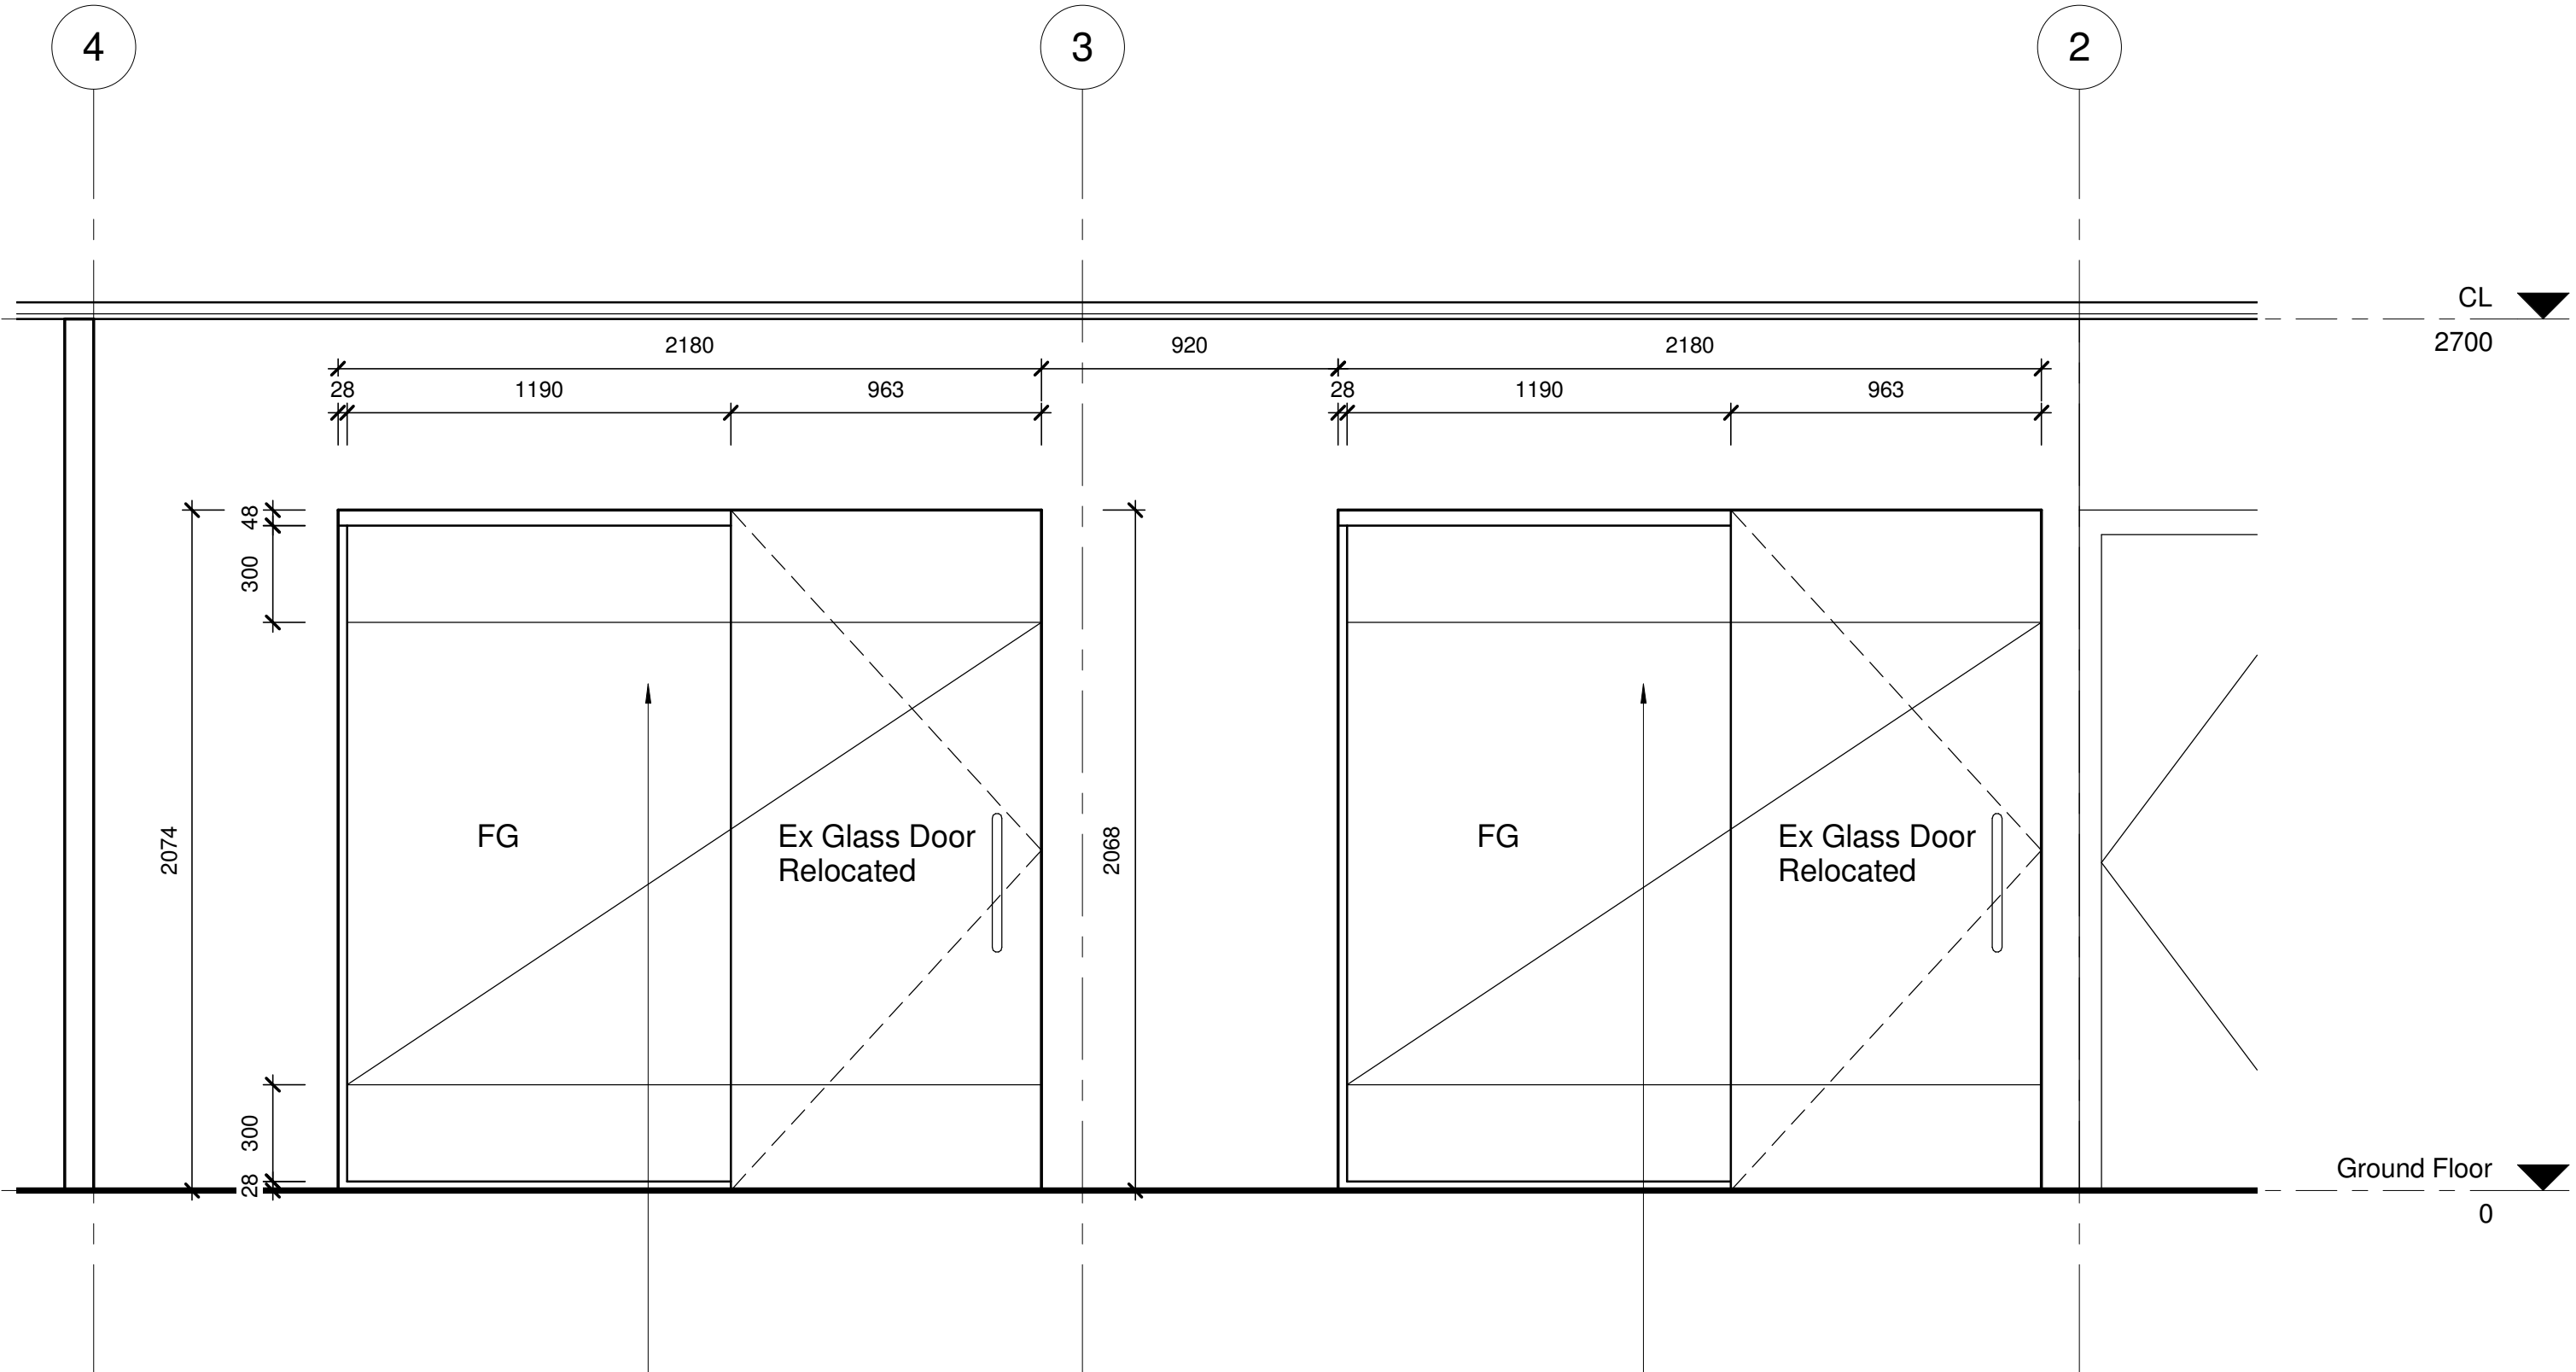

Drawing Sheet Title
Sliding Door Details

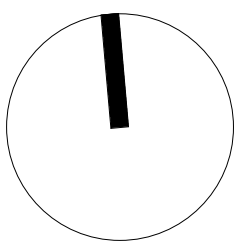

Amendments		
Issue	Revision	Date
A	Preliminary	26.10.09

CLIENT Fast Fix Finance	DATE 26.10.09	DRAWN GH	SCALE 1 : 20
PROJECT Fast Fix Finance	JOB No. 09065	CHECKED -	APP'D -
LOCATION	DRAWING No. A105	ISSUE	

ceolin myers

CeolinMyers Pty Ltd
 ACN 136 661 928
 www.ceolinmyers.com

Po Box 640 Spring hill
 Brisbane Q 4004
 info@ceolinmyers.com